


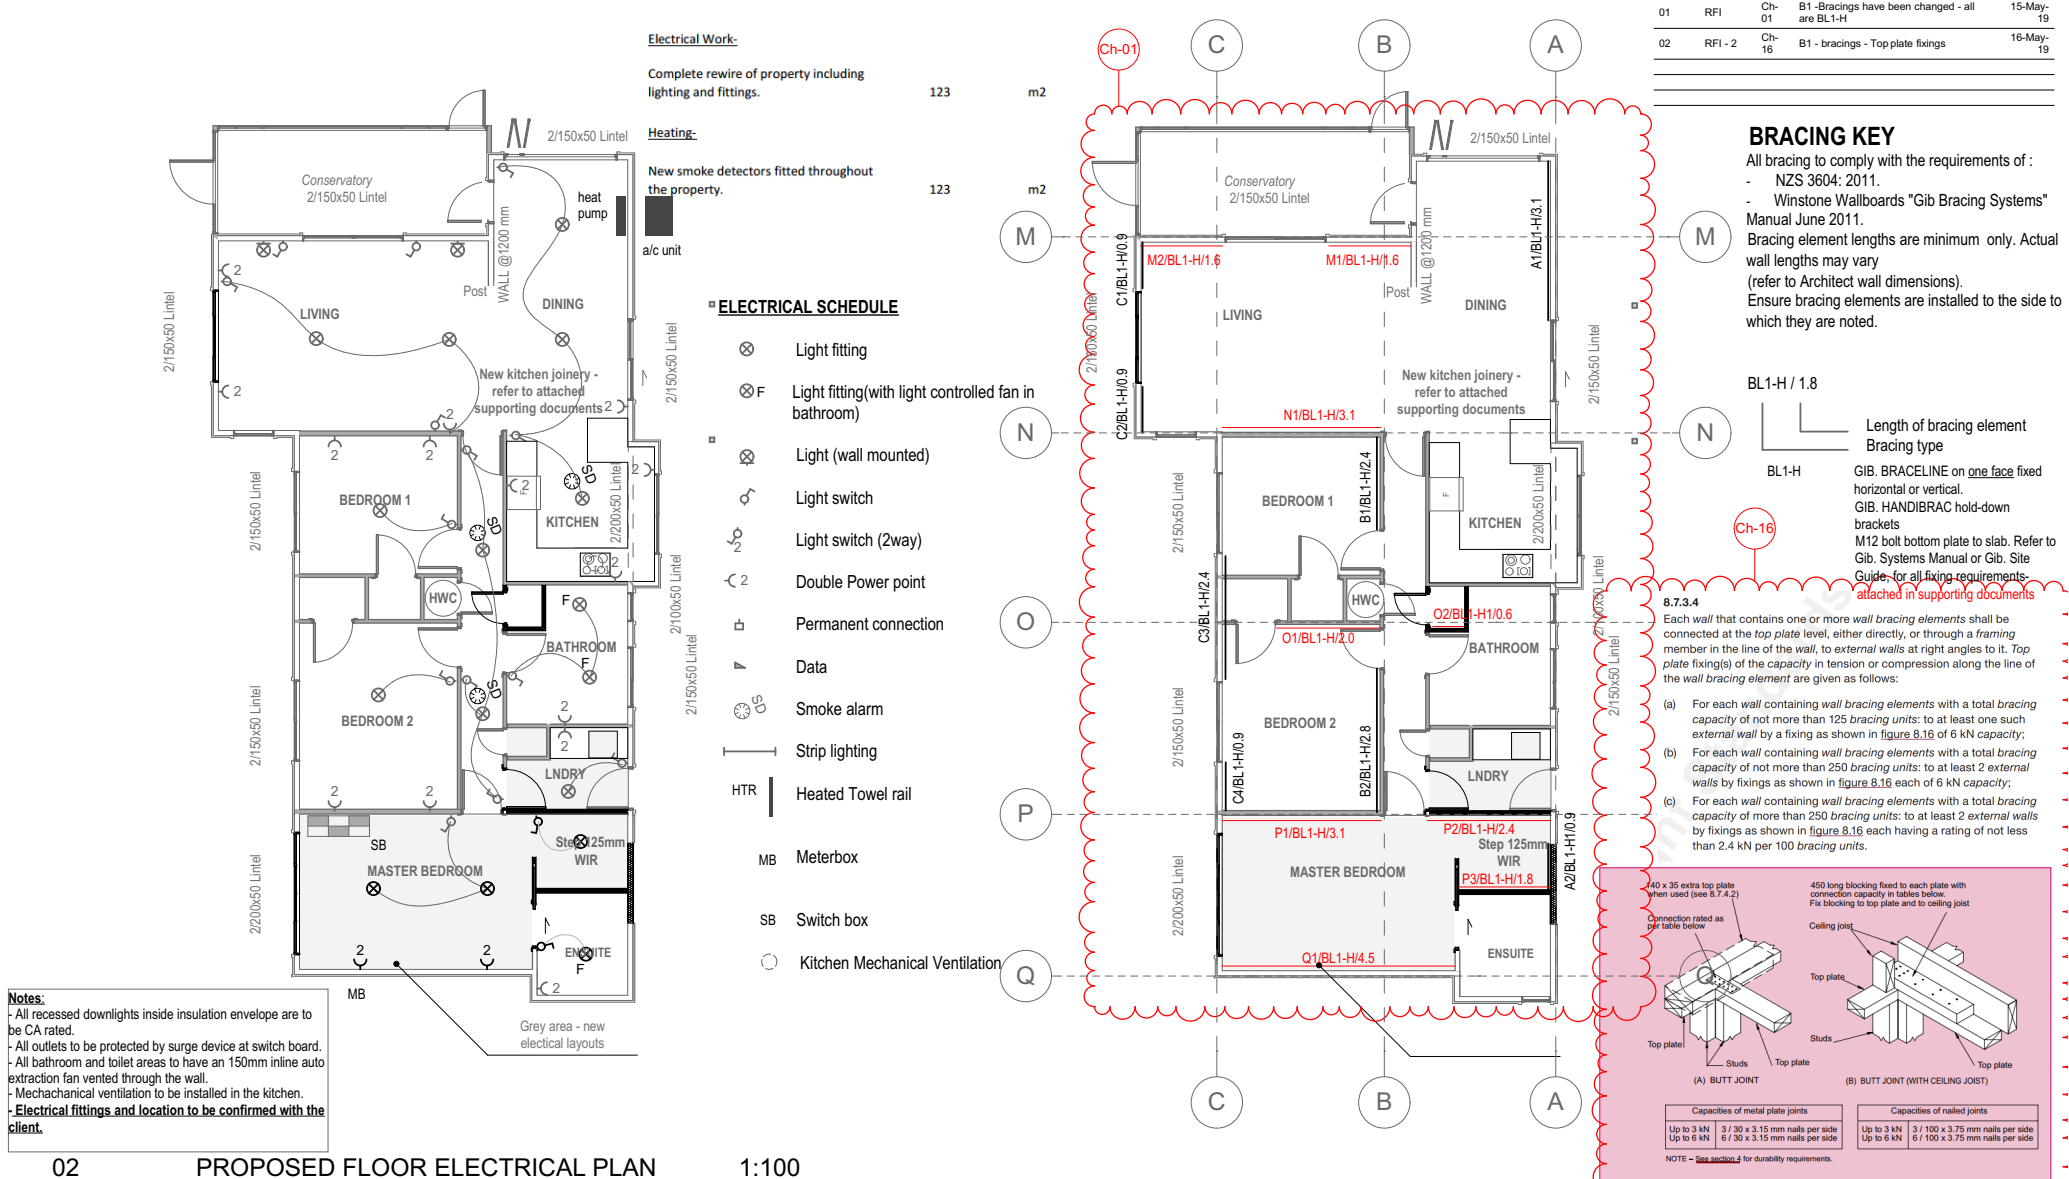

02 PROPOSED FLOOR ELECTRICAL PLAN 1:100

TO BE READ IN CONJUNCTION WITH ALL OTHER ARCHITECTURAL DRAWINGS AND SPECIFICATIONS - IF IN DOUBT - ASK

STATUS:

CONSULTANTS:



38 Colombo Street
Cashmere,
Christchurch 8022
PHONE: 03 331 6026
office@peterdunbar.co.nz
www.peterdunbar.co.nz

SUE ATKINS

Mapua

28A ARANUI ROAD

SHEET TITLE:

ELECTRICAL & BRACING PLAN

REVISION #: 02

Designed by: Peter Dunbar

Drawn by: Jiri Silva

ISSUED: 16-May-19

PROJECT #: AA19004 - 2

SHEET

3.02